


HARRIS COUNTY MUNICIPAL UTILITY DISTRICT No. 191

Plans for Proposed


DETENTION POND

to serve

CHAMPIONS ARBOR

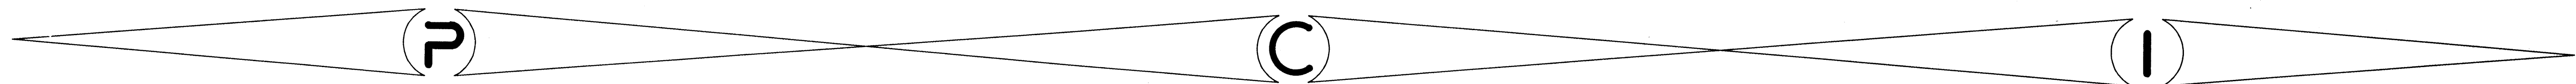

TITLE	DRAWING INDEX	SHEET NO.
COVER SHEET		1
NOTES		2
AREA DRAINAGE LAYOUT		3
OVERALL LAYOUT		4
POLLUTION PREVENTION PLAN		5
CROSS SECTIONS and DETAILS		6
STORM SEWER STANDARD DETAILS		7
POLLUTION CONTROL STANDARD DETAILS		8
TRENCH SAFETY STANDARD DETAILS		9
HCFC D STANDARD OUTFALL DETAILS		10
HCFC D CONCRETE CHANNEL PAVING DETAILS		11

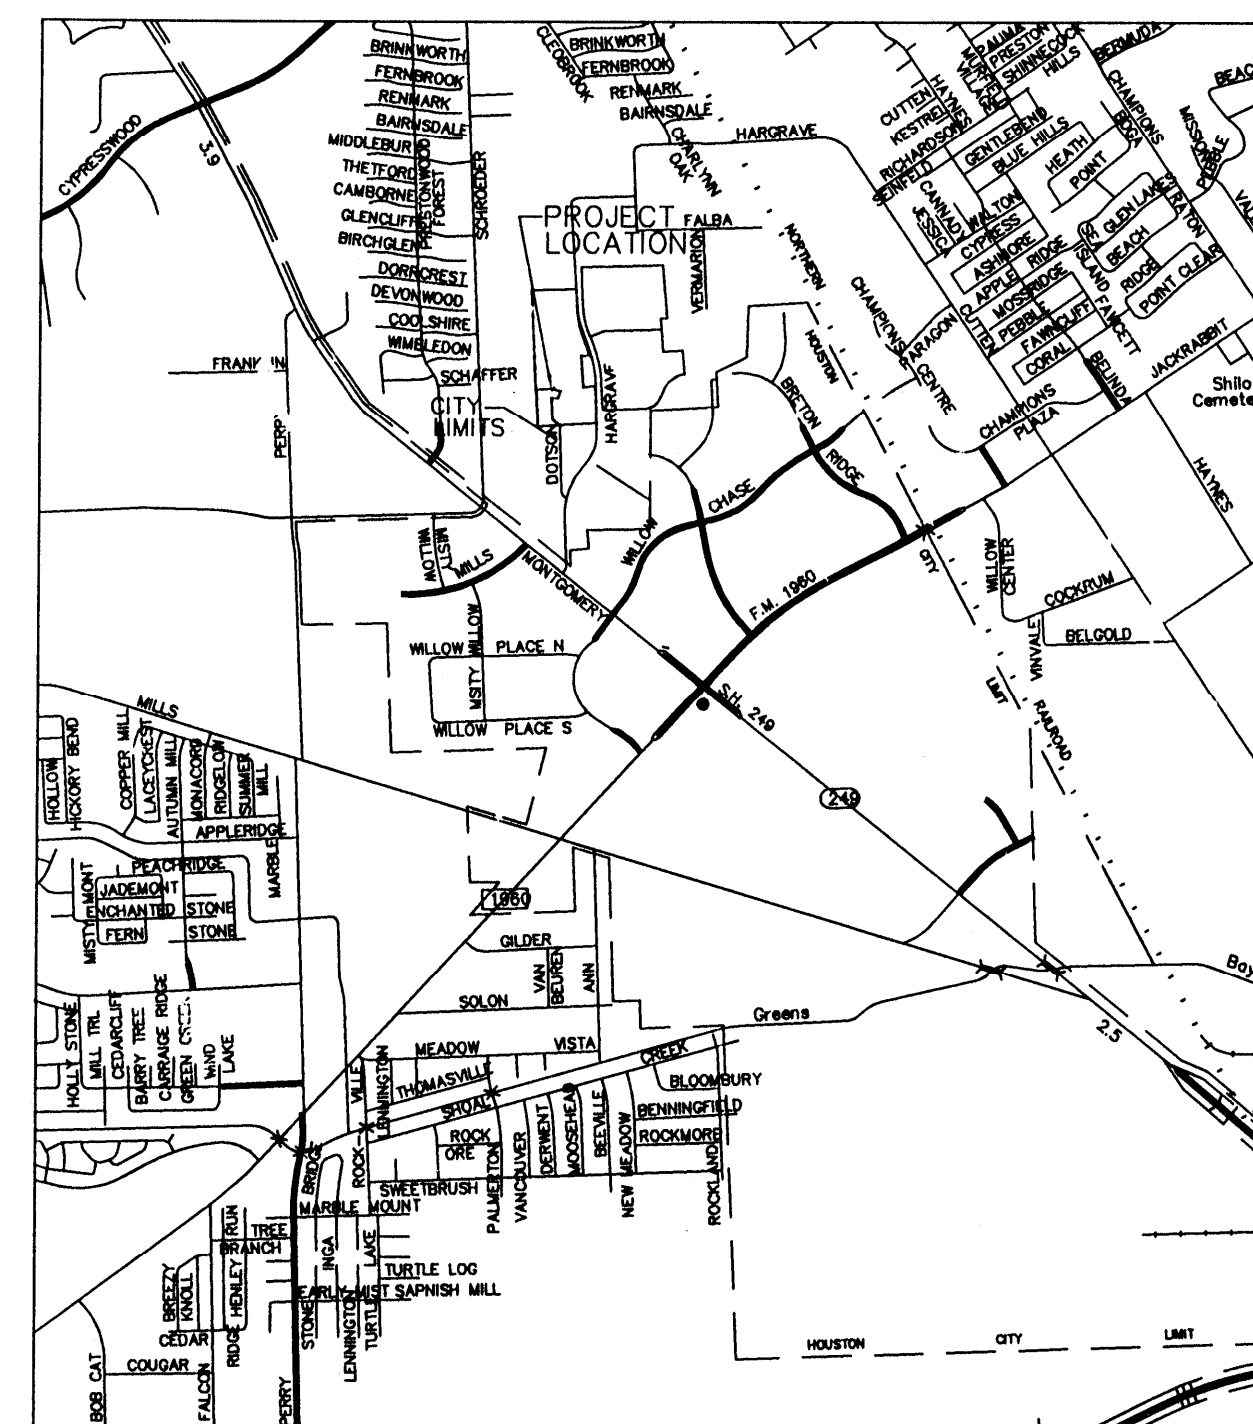

LOCATION MAP
HARRIS COUNTY, TEXAS
MAP REFERENCY
KEY MAP NO. 370A-E
LAMBERT MAP NO. 4966(639)-B-1

APPROVED
CITY OF HOUSTON

Herbert Lum
CITY ENGINEER
HERBERT LUM, P.E.

1-11-2000
DATE

Jerry E. King
DIRECTOR OF PUBLIC WORKS AND ENGINEERING
JERRY E. KING, P.E.

1-11-2000
DATE

CITY DWG. NO:
SHEET NO. 1 OF 11 SHEETS

"PRIOR TO THE CONSTRUCTION OF THESE FACILITIES WITHIN OR BY THE DISTRICT, THE DISTRICT OR ITS ENGINEER WILL GIVE WRITTEN NOTICE BY REGISTERED OR CERTIFIED MAIL TO THE DIRECTOR OF PUBLIC WORKS AND ENGINEERING STATING THE DATE SUCH CONSTRUCTION WILL BE COMMENCED."

"CONTRACTOR SHALL NOTIFY THE CITY OF HOUSTON, DEPARTMENT OF PUBLIC WORKS AND ENGINEERING, ENGINEERING CONSTRUCTION AND REAL ESTATES GROUP (TELEPHONE (713)837-7000) 48 HOURS BEFORE STARTING WORK ON THIS PROJECT."



DEVELOPER:
SEDONA WOODS, LTD.

JOB NO. 481
DATE: NOVEMBER 1999

HCFC D LOG. NO. 112221
HCFC D UNIT P150-00-00

COH LOG.
PROVIDENT CC
1200 WEST 11TH ST.
HOUSTON, TEXAS 77008
(713)802-1019



CHAMPIONS ARBOR DETENTION JOB# 481