


HIGHLAND MANAGEMENT, INC.

on behalf of


HARRIS COUNTY MUNICIPAL UTILITY DISTRICT No. 191

Plans for Proposed DETENTION FACILITIES to serve HIGHLAND TIMBERS SECTION 1 & 2

JOB# 466 HIGHLAND TIMBERS DETENTION HCMUD 191

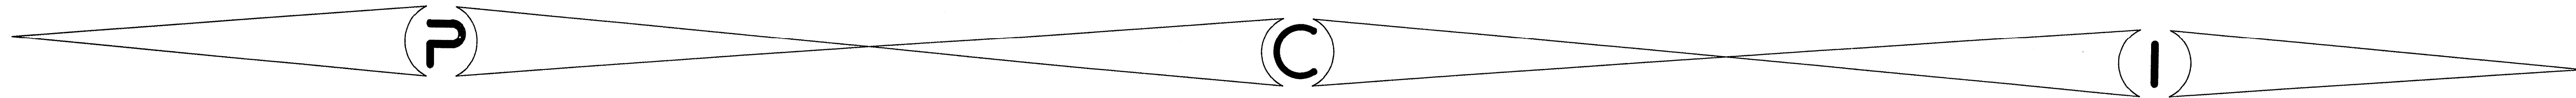

TITLE	DRAWING INDEX	SHEET NO.
COVER SHEET		1
NOTES		2
AREA DRAINAGE LAYOUT		3
OVERALL LAYOUT		3A
POLLUTION PREVENTION PLAN		3B
CROSS SECTIONS and DETAILS		3C
PLAN and PROFILE		4
STORM SEWER STANDARD DETAILS		5
POLLUTION CONTROL STANDARD DETAILS		6
TRENCH SAFETY STANDARD DETAILS		7
HCFCO STANDARD OUTFALL DETAILS		8
HCFCO CONCRETE CHANNEL PAVING DETAILS		8A
PAVING REPAIR DETAILS		9

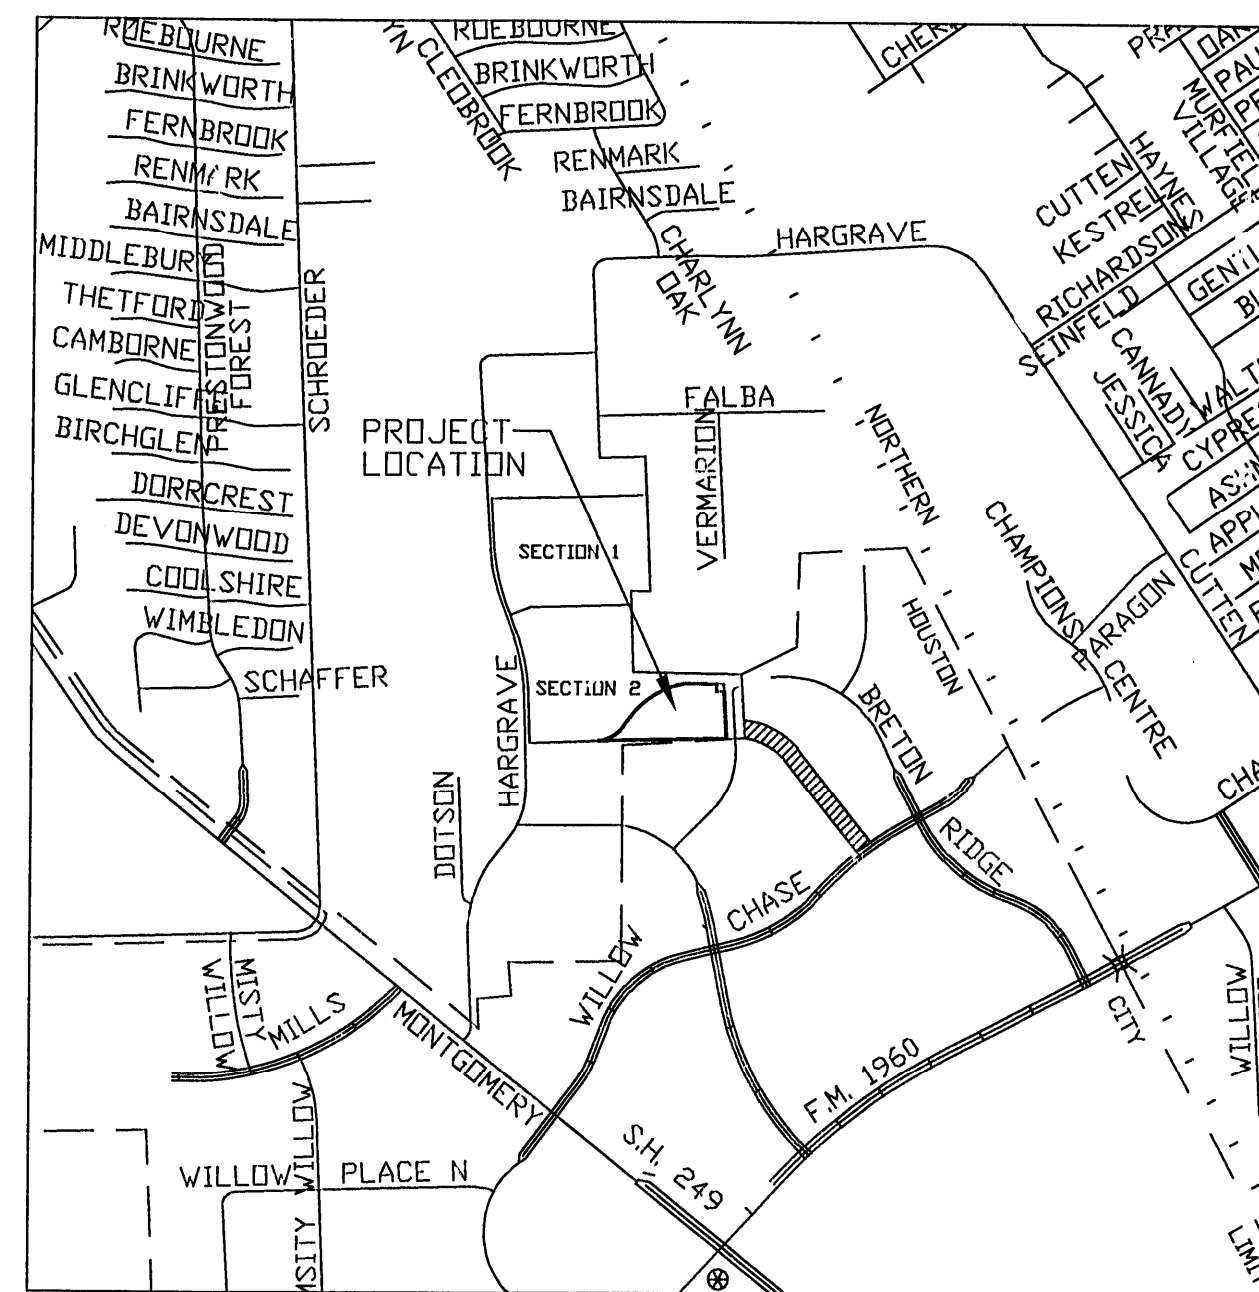

LOCATION MAP
HARRIS COUNTY, TEXAS
MAP REFERENCE
KEY MAP NO. 370A-B
LAMBERT MAP NO. 4966(639)-B-1

APPROVED
CITY OF HOUSTON

Herbert Lum
CITY ENGINEER
HERBERT LUM, P.E. 8-24-99
DATE

Jerry E. King
DIRECTOR OF PUBLIC WORKS AND ENGINEERING
JERRY E. KING, P.E. 8-24-99
DATE

CITY DWG. NO:
SHEET NO. 1 OF 9 SHEETS


"PRIOR TO THE CONSTRUCTION OF THESE FACILITIES WITHIN OR BY THE DISTRICT, THE DISTRICT OR ITS ENGINEER WILL GIVE WRITTEN NOTICE BY REGISTERED OR CERTIFIED MAIL TO THE DIRECTOR OF PUBLIC WORKS AND ENGINEERING STATING THE DATE SUCH CONSTRUCTION WILL BE COMMENCED."

"CONTRACTOR SHALL NOTIFY THE CITY OF HOUSTON, DEPARTMENT OF PUBLIC WORKS AND ENGINEERING, ENGINEERING CONSTRUCTION AND REAL ESTATES GROUP (TELEPHONE (713)837-7000) 48 HOURS BEFORE STARTING WORK ON THIS PROJECT."

DEVELOPER:
HIGHLAND MANAGEMENT, INC.

JOB NO. 466
DATE: JUNE 1999

HCFCO LOG. NO. 103497
HCFCO UNIT P150-00-00

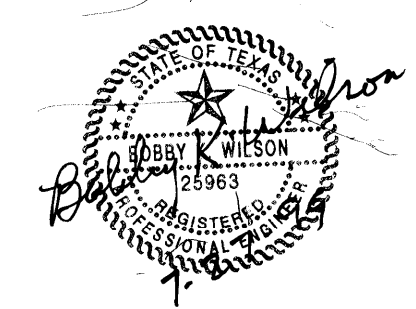

COH LOG. NO. 99-0648

PCI PROVIDENT CONSULTING, INC.
1200 WEST 11TH ST.
HOUSTON, TEXAS 77008
(713)802-1019