
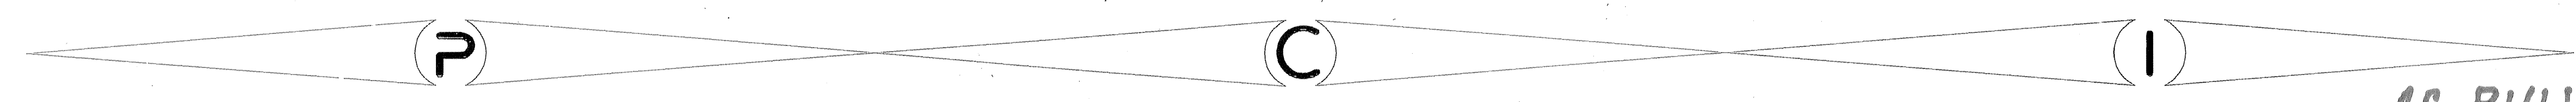



VILLAS at WILLOWBROOK
on behalf of
VILLAS at WILLOWBROOK, L.L.P.
plans of proposed
WATER, SANITARY, STORM SEWER
and PAVING IMPROVEMENTS
to serve
VILLAS at WILLOWBROOK
in
HARRIS COUNTY M.U.D. 191
HARRIS COUNTY, TEXAS

H.C.P.I. R# 207217
RELIANT ID# 19747
SWBTC ID#
C.O.H. LOG# -04-1556
JOB #482 U&P
DATE: JULY 2005

PROVIDENT CONSULTING, INC.
1405 ALLSTON ST.
HOUSTON, TEXAS 77008
(713)802-1019

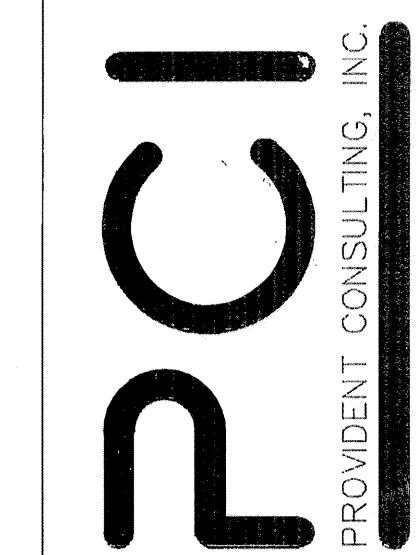

AS BUILT DRAWINGS
Bobby K. Wilson P.E.

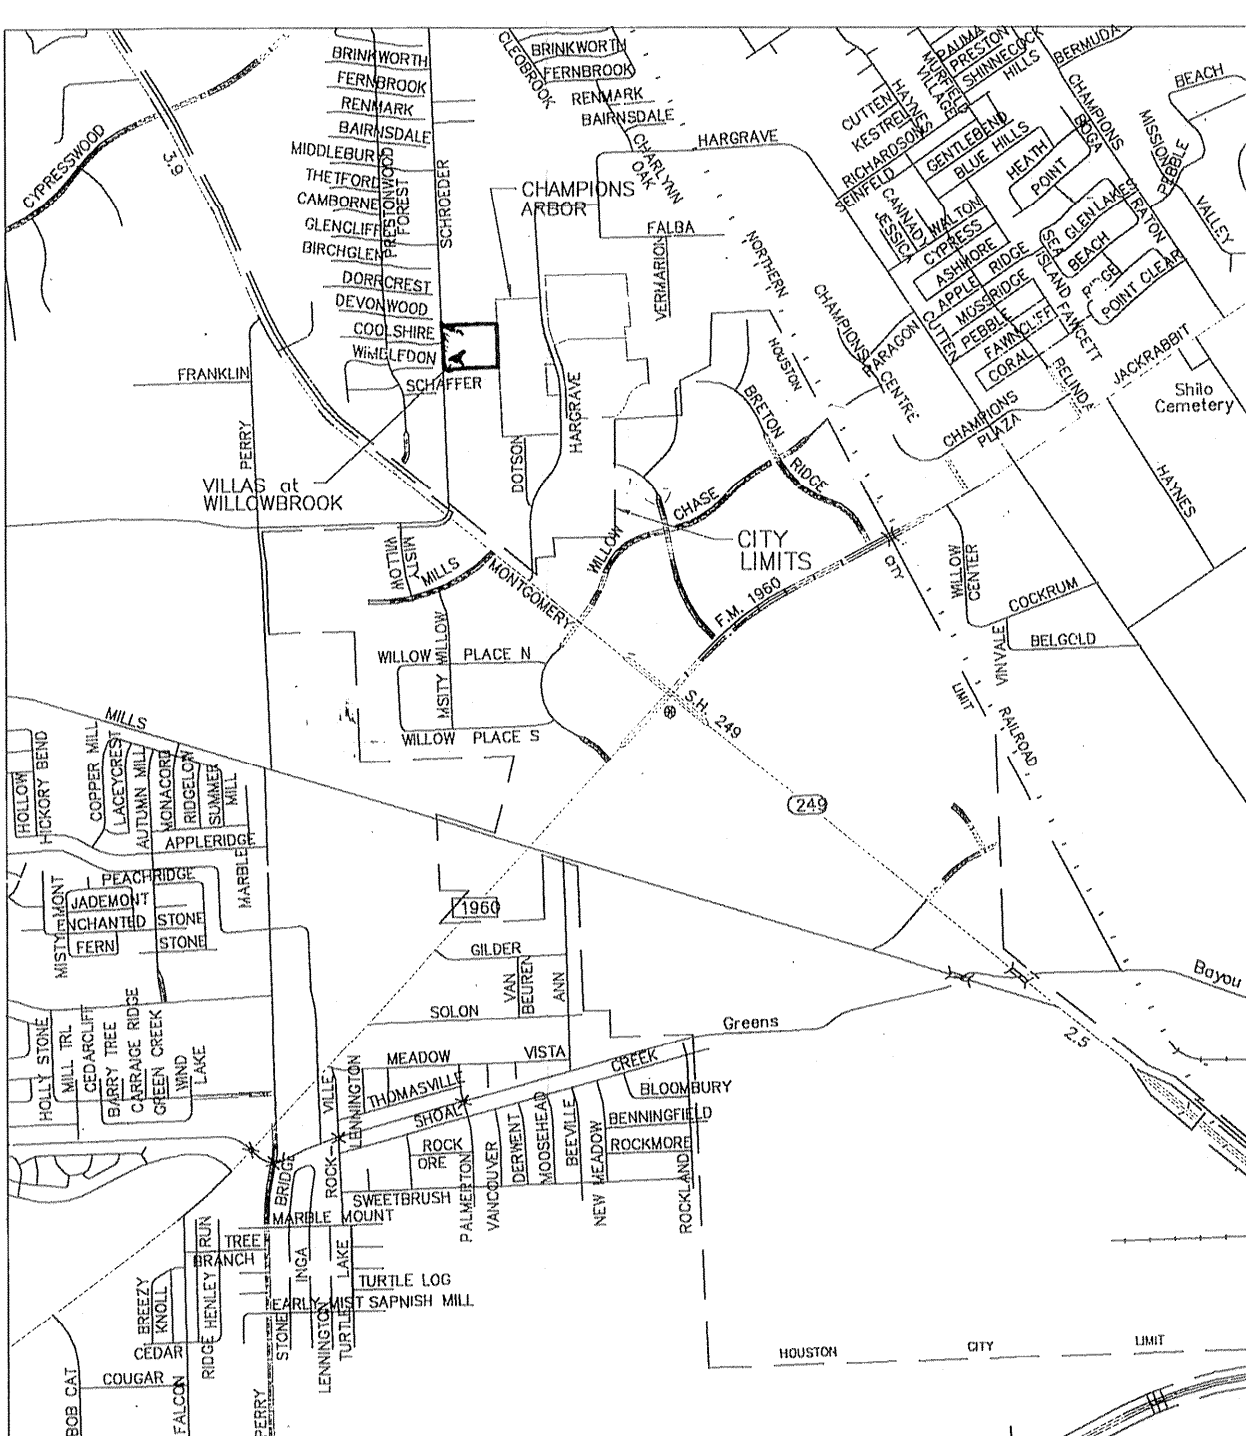

LOCATION MAP
HARRIS COUNTY, TEXAS
MAP REFERENCY
KEY MAP NO. 369 D&H
LAMBERT MAP NO. 4966(639)-B-1

TITLE	DRAWING INDEX	SHEET NO.
COVER		1
HARRIS COUNTY EXPRESS REVIEW SHEET		2
GENERAL NOTES		3
DRAINAGE AREA MAP & STORM WATER QUALITY PLAN		4
STORM WATER POLLUTION PREVENTION PLAN		5
PAVING & DRAINAGE OVERALL LAYOUT		6
SANITARY & WATER OVERALL LAYOUT		7
PLAN & PROFILES		8-12
DETENTION POND LAYOUT		13
DETENTION OUTFALL & CONTROL BOX DETAILS		14
WATER DETAILS		15
SANITARY SEWER DETAILS		16
STORM SEWER DETAILS		17
WHEELCHAIR RAMP & VARIOUS DETAILS		18
STORM WATER QUALITY UNIT DETAILS		19
HCFCO OUTFALL AND INTERCEPTOR STRUCTURE DETAILS		20
STORM SEWER, PUMP STATION ELECTRICAL LAYOUTS		21-23
STORM SEWER, PUMP STATION STRUCTURAL		24

TITLE	STREET INDEX	SHEET NO.
STRATFORD WAY		8
VILLA DE NORTE ST.		9
VILLA ARBOR DR.		9
WILLOWBROOK VILLA DR.		10
VILLA ARCA ST.		10
VILLA PALMAS ST.		11
VISTA DE ORO ST.		11
VILLA LAGO LANE		12

* EXCEPT FOR STRATFORD WAY, ALL PROPOSED
SANITARY SEWER, STORM SEWER, AND WATER
LINES, EXCEPT FOR THE FIRE LOOP ARE PRIVATE.

Privately owned utilities within private properties
shall be reviewed
and released by the County Engineer's Office.


PRIOR TO THE CONSTRUCTION OF THESE FACILITIES WITHIN OR BY THE DISTRICT, THE DISTRICT OR ITS ENGINEER WILL GIVE WRITTEN NOTICE BY THE REGISTERED OR CERTIFIED MAIL TO THE DIRECTOR OF PUBLIC WORKS AND ENGINEERING, CITY OF HOUSTON, STATING THE DATE SUCH CONSTRUCTION WILL BE COMMENCED.

"STORM WATER QUALITY PRE-INSPECTION REQUIREMENTS":
THE PROPERTY OWNER OR THE CONTRACTOR SHALL CONTACT THE HARRIS COUNTY STORM WATER QUALITY PERMITTING SECTION AT 713-956-3000 FOR A PRE-CONSTRUCTION INSPECTION PRIOR TO COMMENCING ANY CLEARING OR CONSTRUCTION ACTIVITIES ON THE SITE.

DEVELOPER:
VILLAS at WILLOWBROOK, L.L.P.
JOB #482-U&P
DATE: JULY 2005



PROVIDENT CONSULTING, INC.
1405 ALLSTON ST.
(713)802-1019
SURVEYED BY: HOVIS SURVEYING CO.
FB NO.

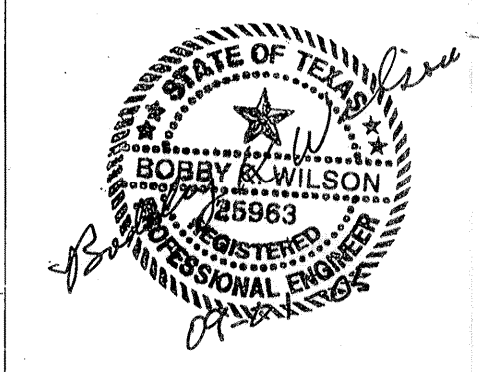

CITY OF HOUSTON
PUBLIC WORKS & ENGINEERING


R.G. Dangle 9/1/05
WATER
STORM WATER QUALITY

Wickman 9-1-05
WASTEWATER
TRAFFIC AND TRANSPORTATION

Forrester 9/1/05
* STORM WATER
WATER PRODUCTION

STREET & BRIDGE

CITY ENGINEER
Richard J. Bullock
DIRECTOR OF PUBLIC WORKS AND ENGINEERING
9/1/05

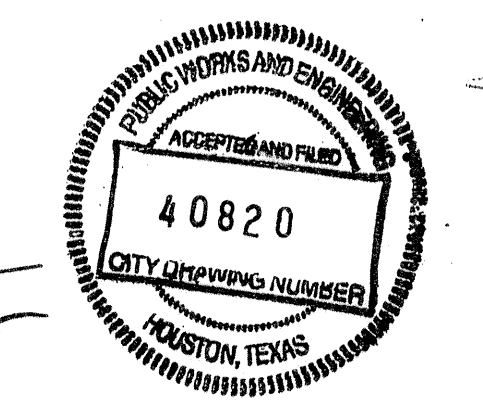

JOB #482 U&P - VILLAS at WILLOWBROOK - UTILITIES, PAVING & DETENTION